
 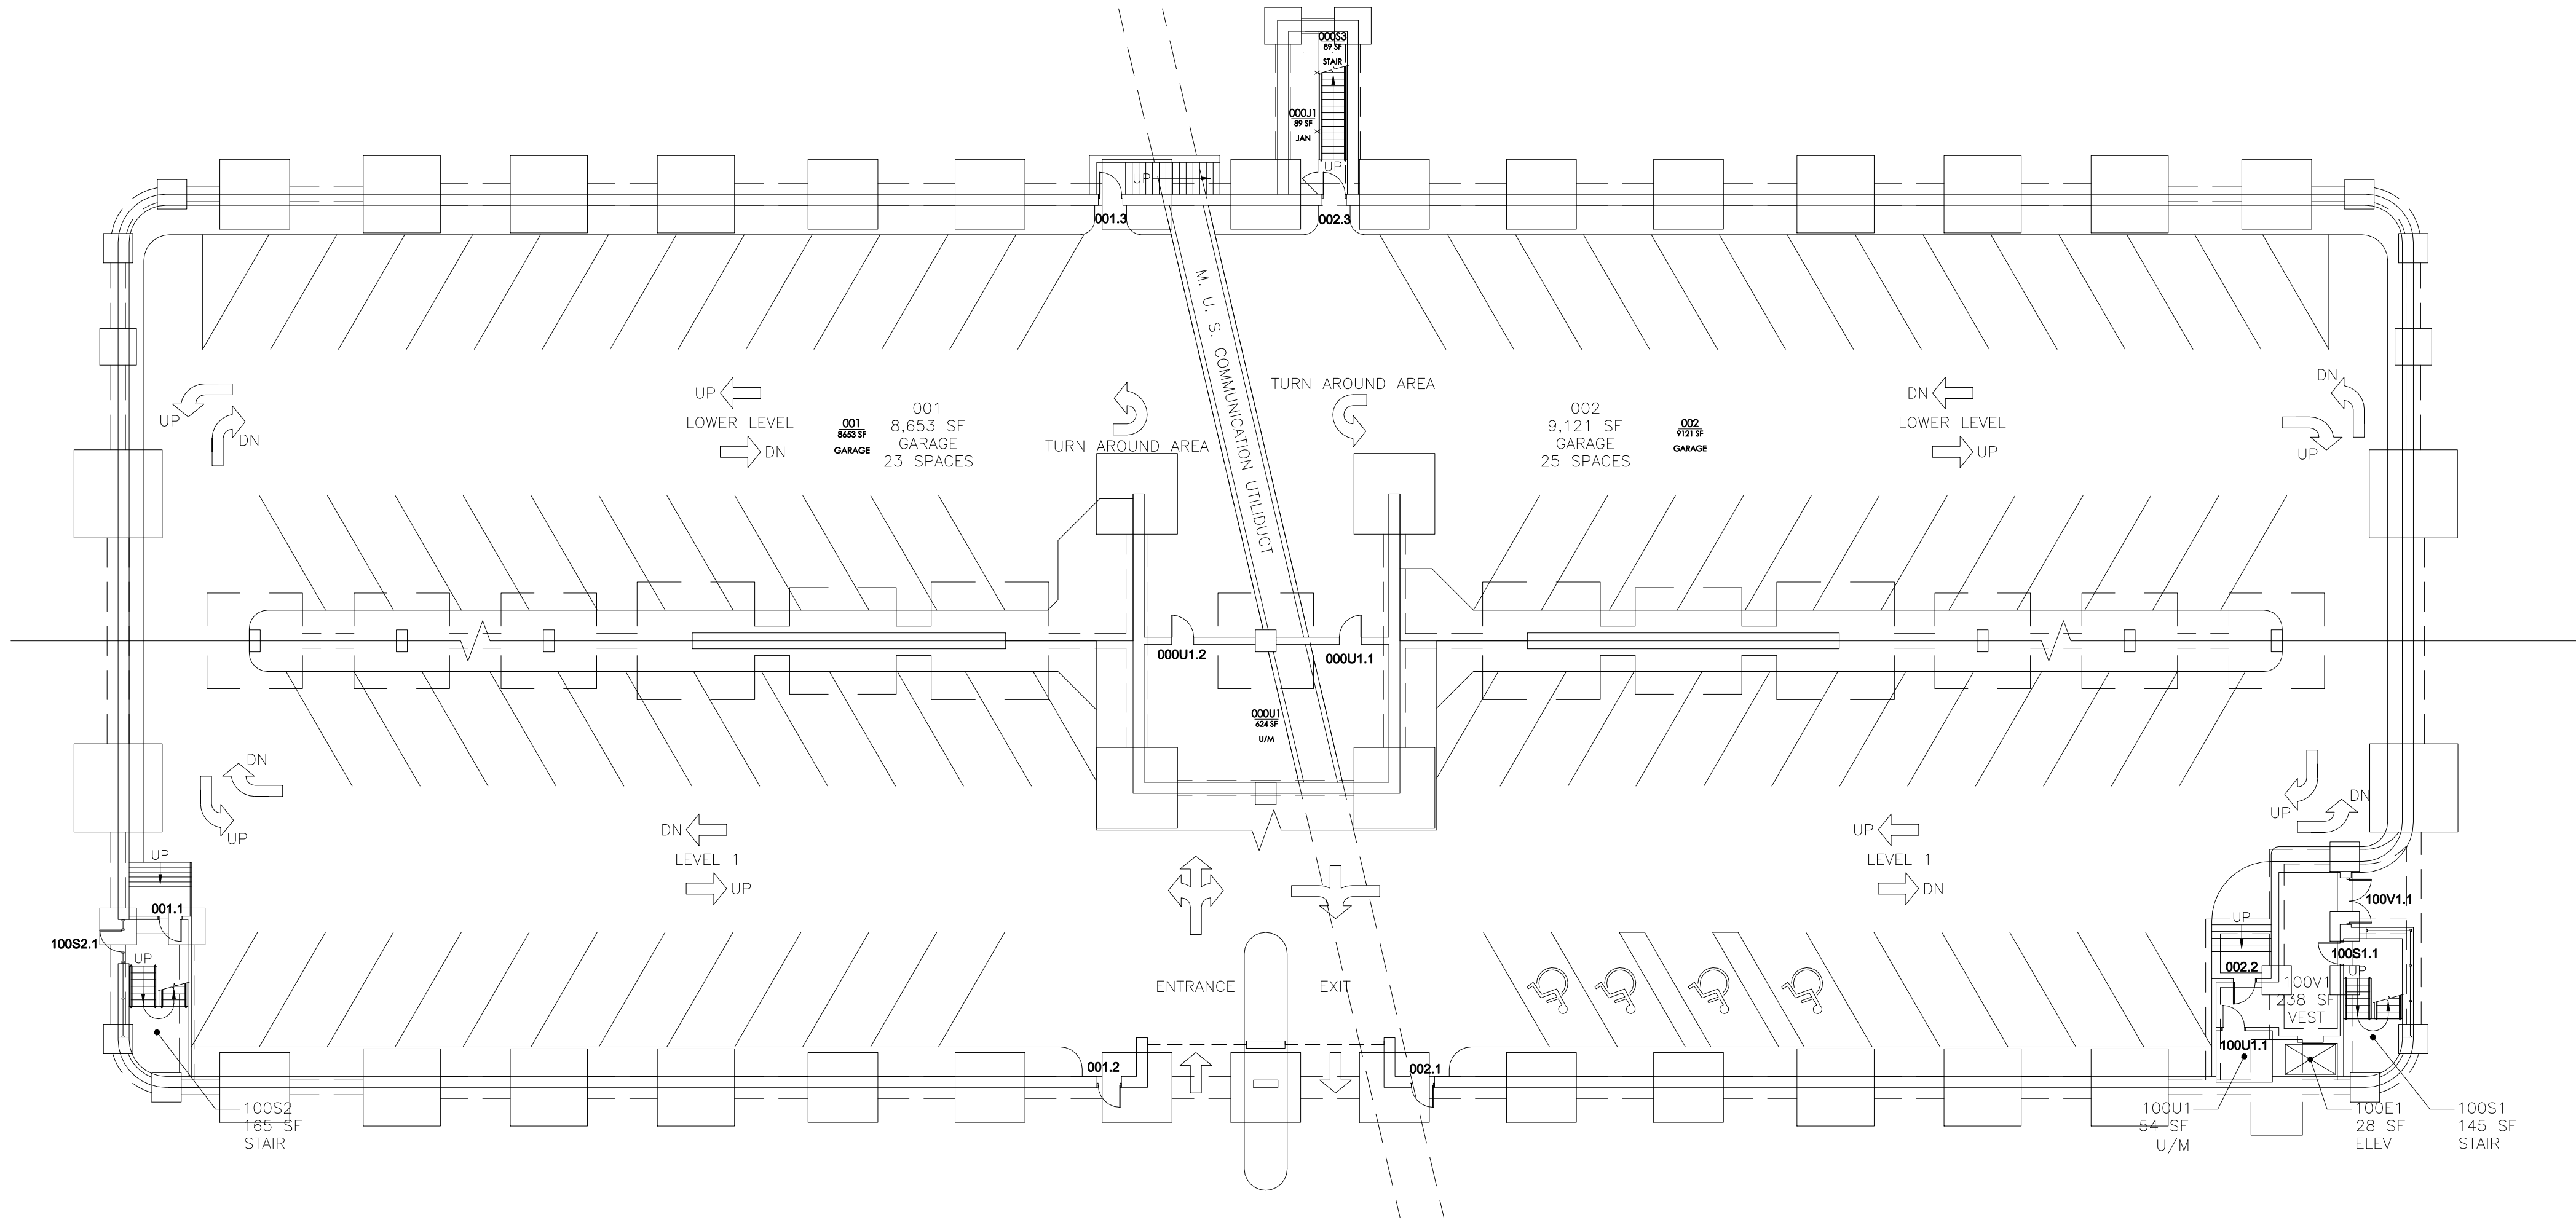


BARNETTE STREET PARKING GARAGE TV654 - BASEMENT FLOOR

SCALE: 1/16" = 1'-0" @ 22X34



FACILITIES SERVICES
DESIGN & CONSTRUCTION
P.O. BOX 758160
FAIRBANKS, AK 99775-8160
907-474-5299
907-474-7554 (fax)
www.uaf.edu/ddc

Consultant:

Stamp:

Project Phase:
FACILITIES INVENTORY

Project Title:

**TV654 - BARNETTE STREET
PARKING GARAGE**

Sheet Contents:
**BASEMENT FLOOR
PLAN**

DATE REVISIONS: BY:

DRAWN RCL

CHECKED

DATE MARCH 2018


SCALE 0" = 1" -1"



Project Number:
TV654

SHEET NO.

A101


1 OF 4

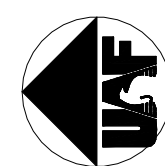

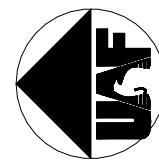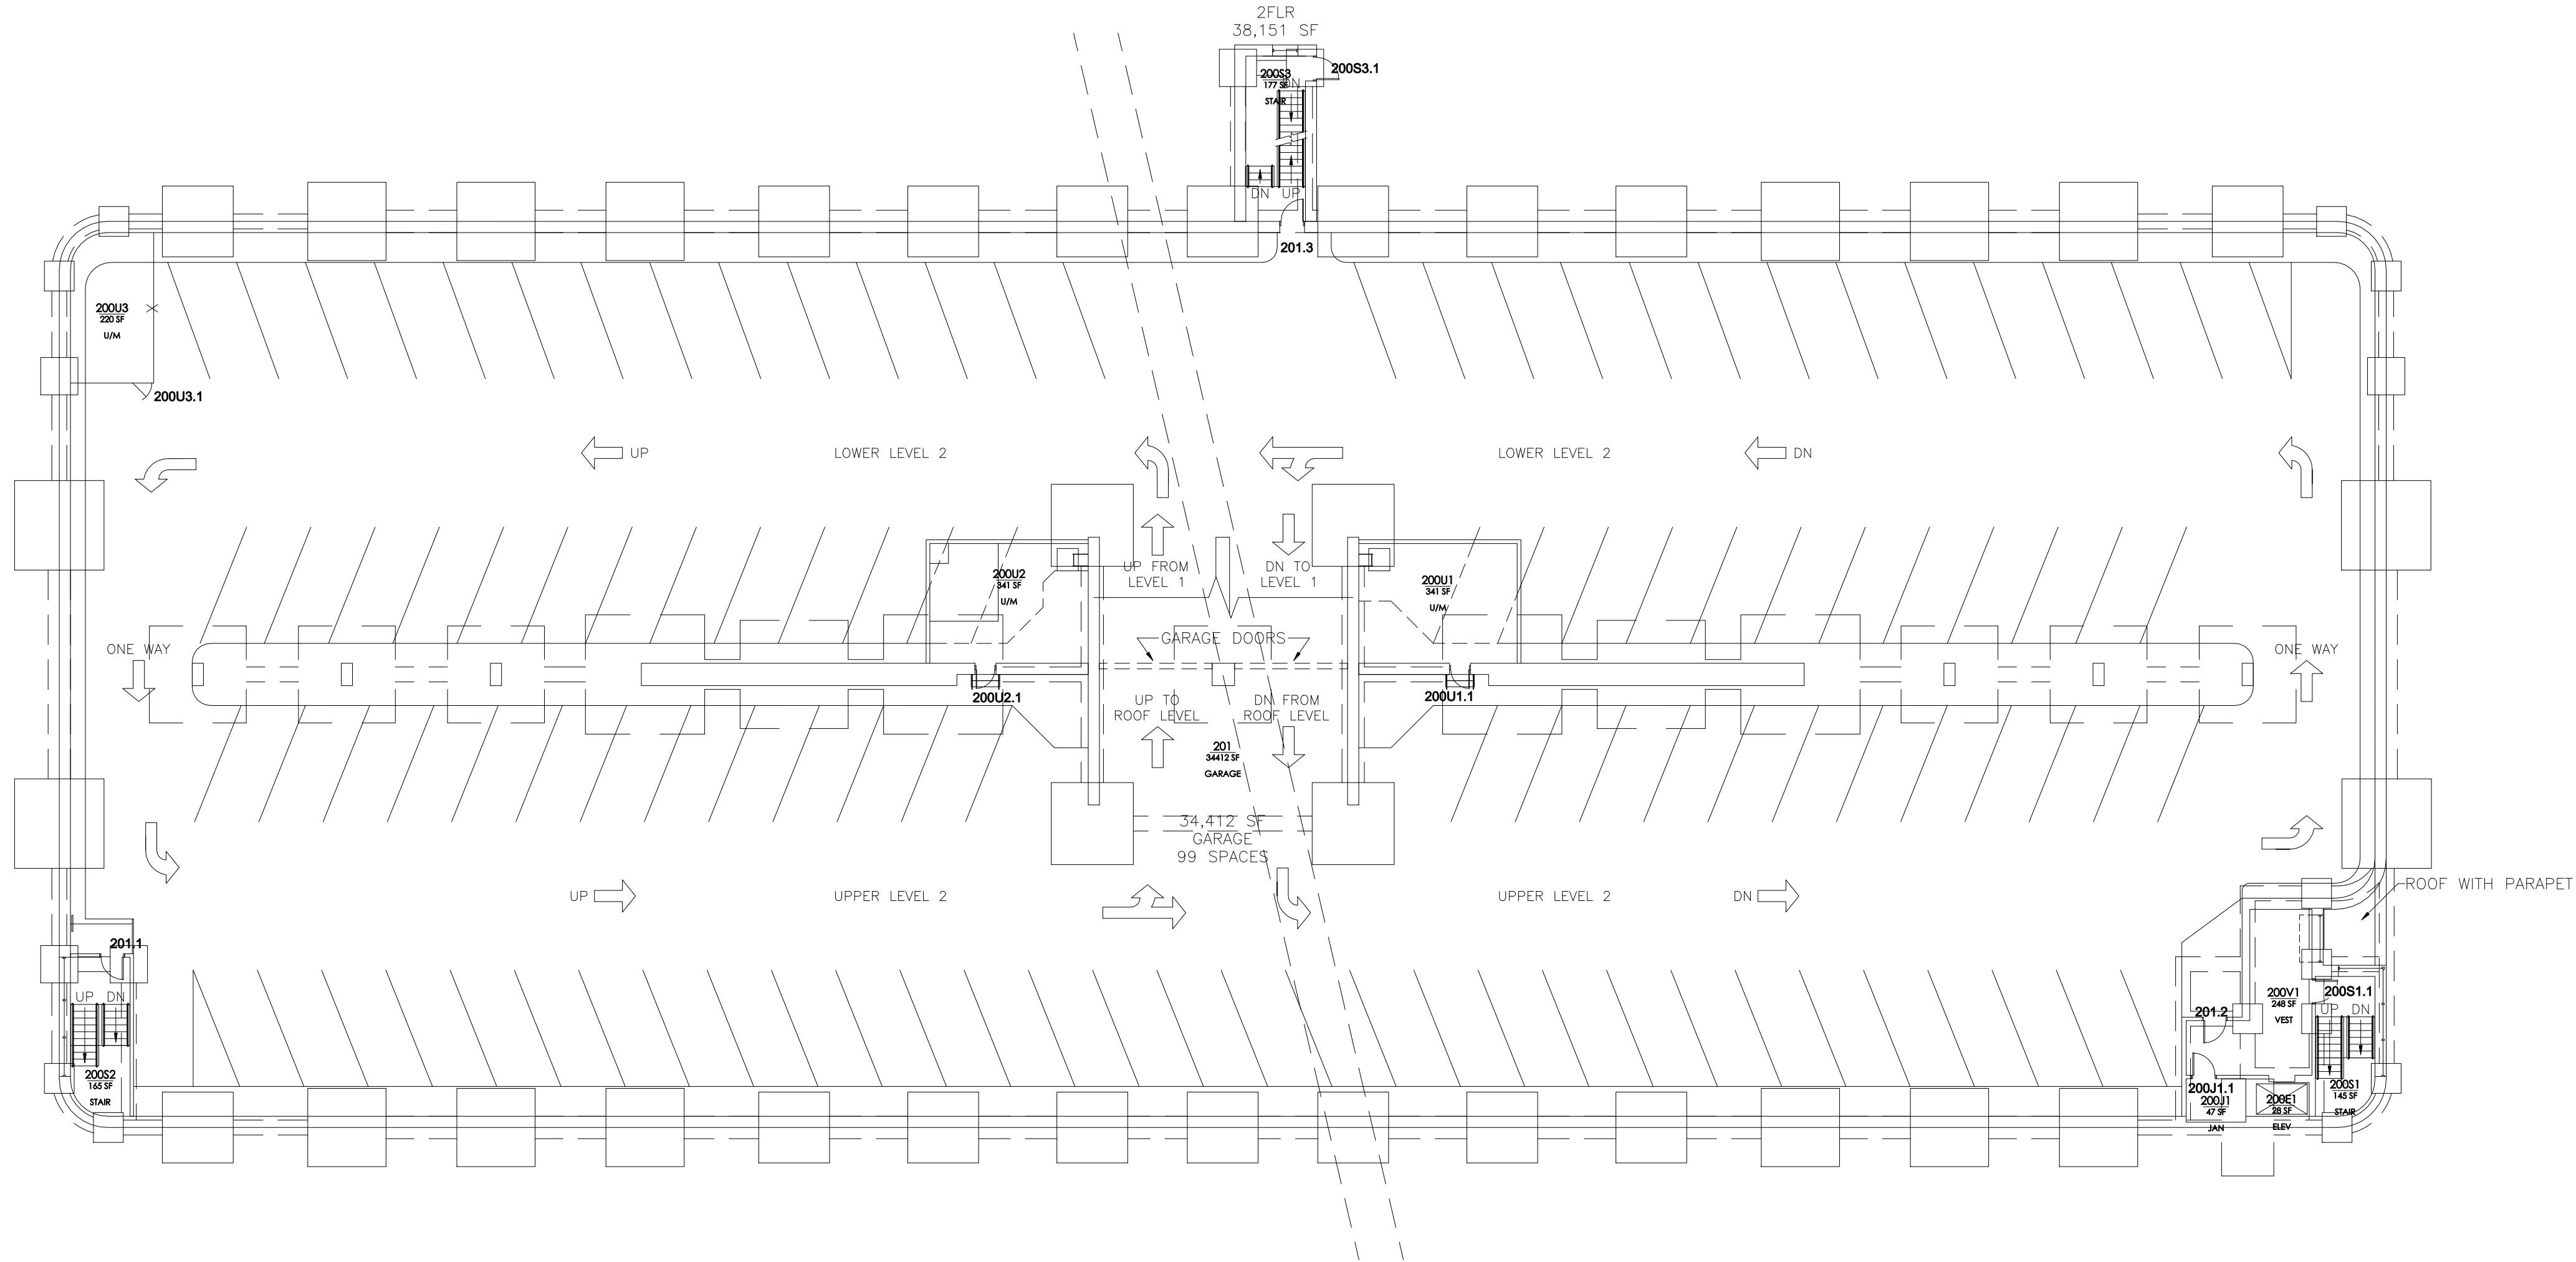

BARNETTE STREET PARKING GARAGE TV654 - 2nd FLOOR

 SCALE: 1/16" = 1'-0" @ 22X34



FACILITIES SERVICES
DESIGN & CONSTRUCTION
P.O. BOX 758160
FAIRBANKS, AK 99775-8160
907-474-5299
907-474-7554 (fax)
www.uaf.edu/ddc

Consultant:

Stamp:

Project Phase:
FACILITIES INVENTORY

Project Title:

**TV654 - BARNETTE STREET
PARKING GARAGE**

Sheet Contents:

SECOND FLOOR PLAN

DATE REVISIONS: BY:

DRAWN RCL

CHECKED

DATE MARCH 2018



SCALE 0" = 1'-0" 1"

Project Number:
TV654


SHEET NO.

A103

3 OF 4

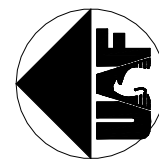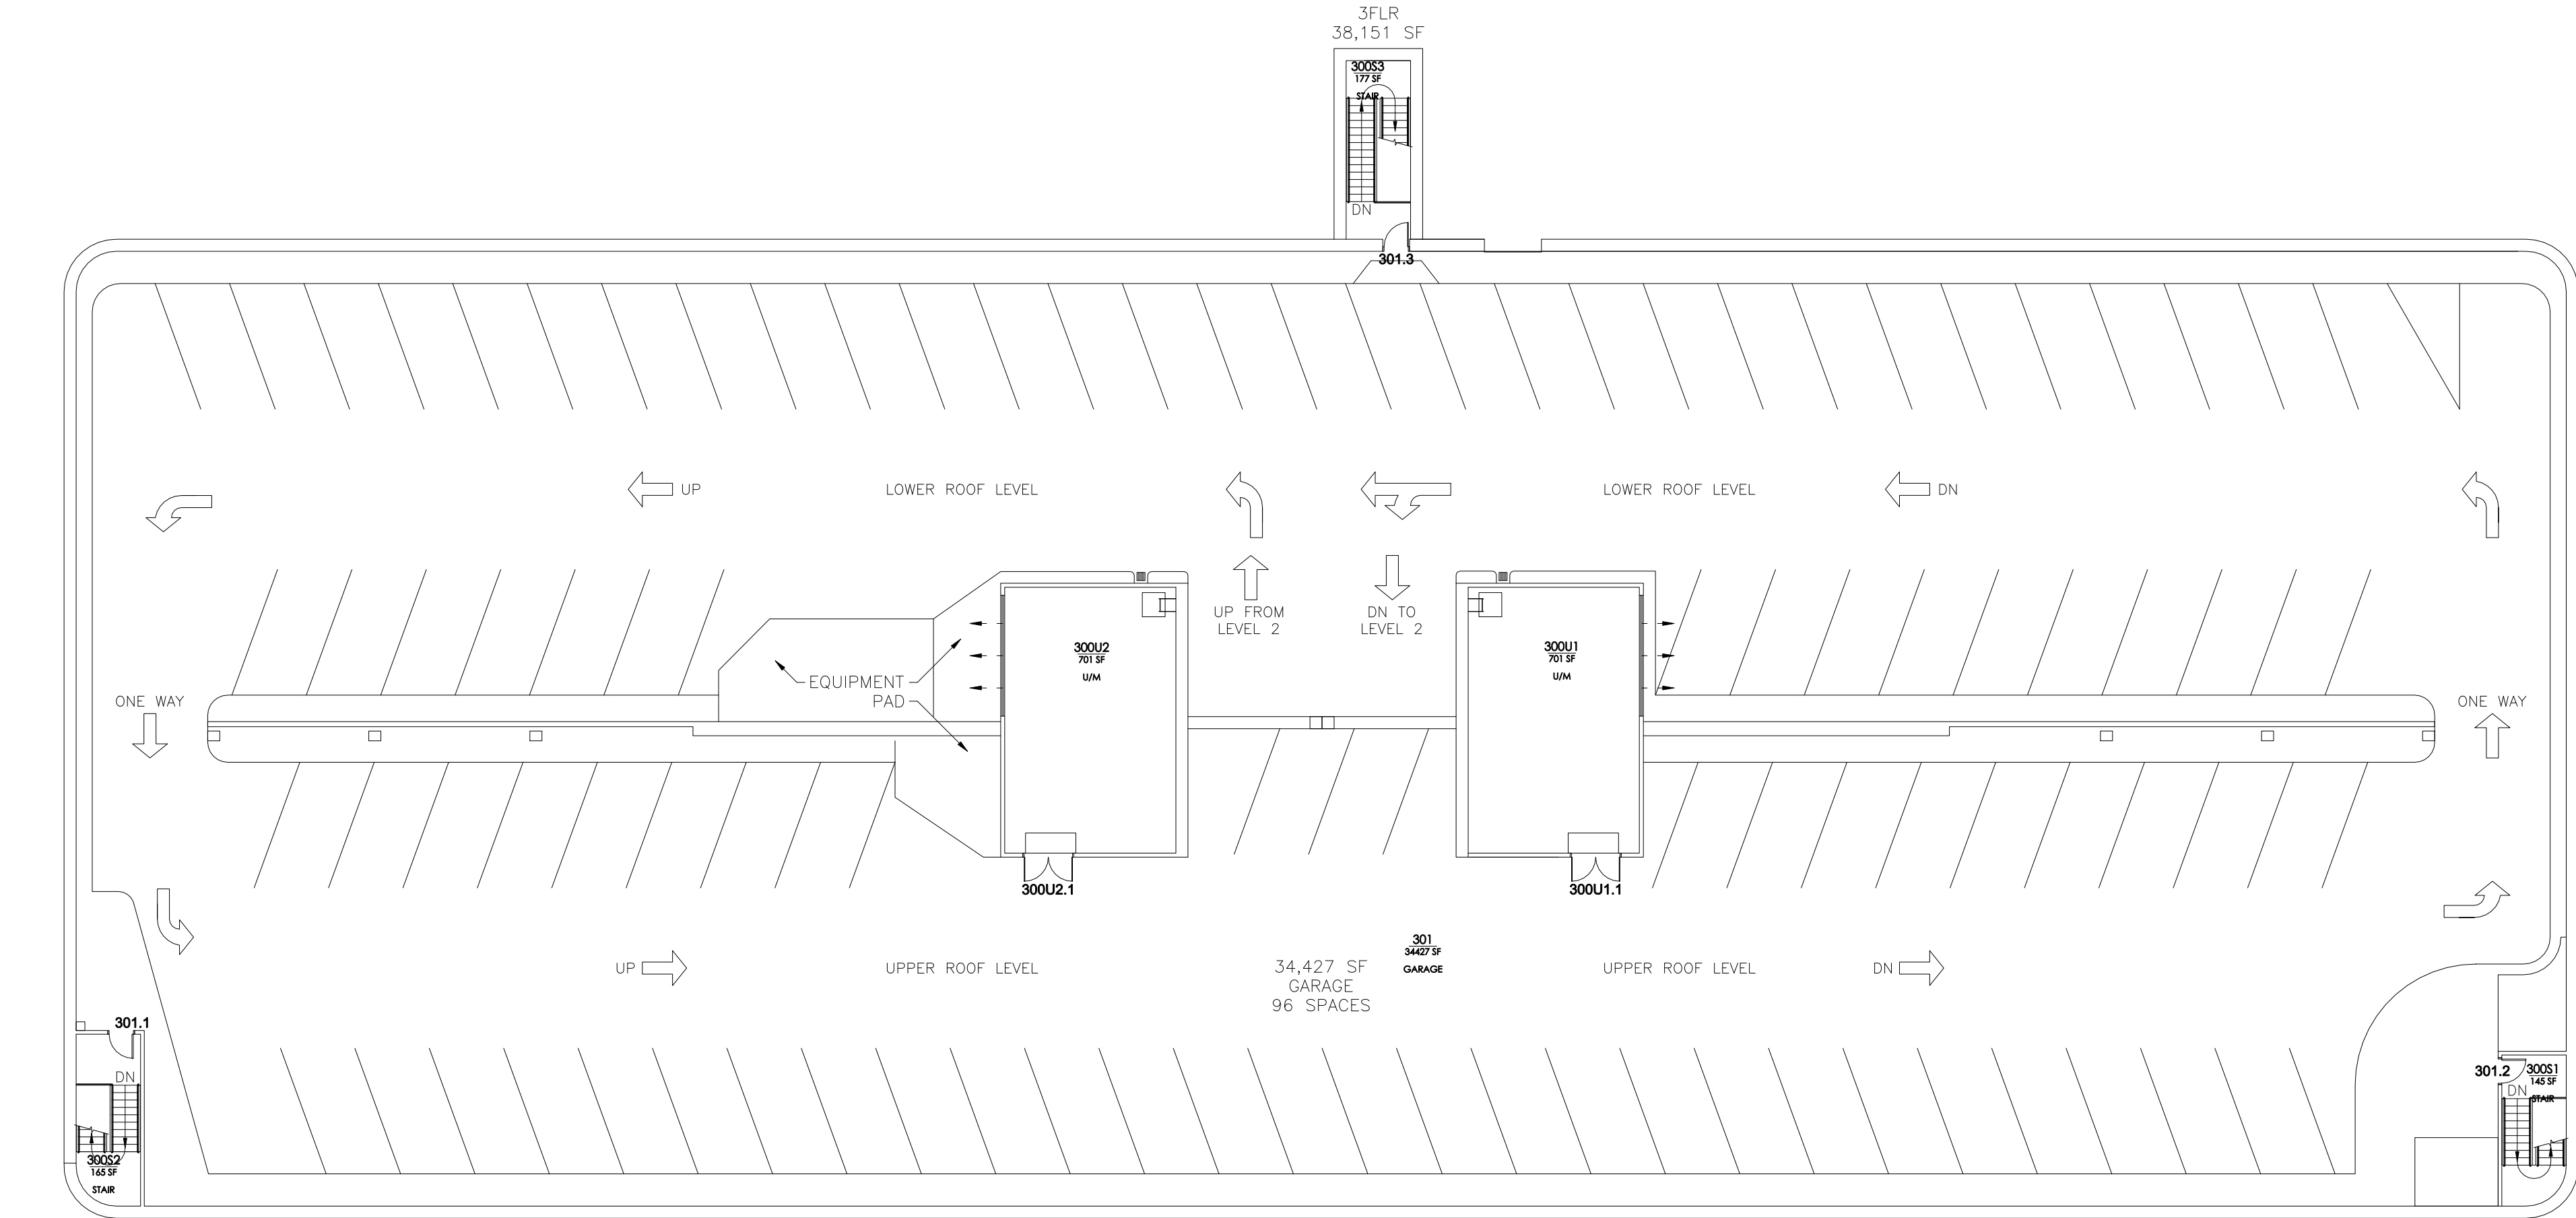

 BARNETTE STREET PARKING GARAGE TV654 - 3rd FLOOR
SCALE: 1/16" = 1'-0" @ 22X34



FACILITIES SERVICES
DESIGN & CONSTRUCTION
P.O. BOX 758160
FAIRBANKS, AK 99775-8160
907-474-5299
907-474-7554 (fax)
www.uaf.edu/ddc

Consultant:

Stamp:

Project Phase:
FACILITIES INVENTORY
Project Title:

**TV654 - BARNETTE STREET
PARKING GARAGE**

Sheet Contents:
THIRD FLOOR PLAN

DATE	REVISIONS:	BY:

DRAWN	RCL
CHECKED	
DATE	MARCH 2018
SCALE	0" = 1"
Project Number:	TV654

SHEET NO.

A104